


DESIGN / BUILD SPECIALISTS
SENATORE INC.
 JAMES P. SENATORE, ARCHITECT • SENATORE CONSTRUCTION

2017

#	DATE	DESCRIPTION

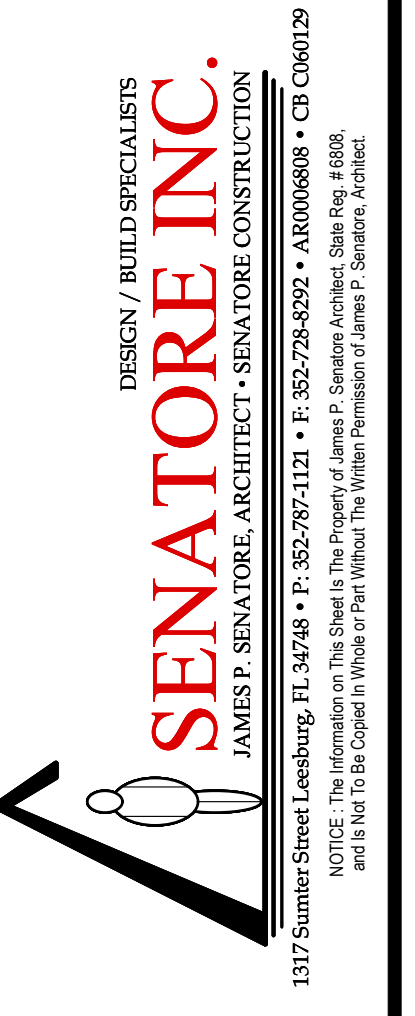

First Contact Ministries
 North Carolina

FIRST FLOOR

DRAWING NO.: 2017 SHEET
 DATE: 10.18.17
 DESIGNED BY: JPS
 DRAWING BY: CAZ
 CHECKED BY: JPS

James P. Senatore
 Architect

Florida No. AR 0006808

FIRST FLOOR PLAN
 Scale: 1/8" = 1'-0"